


 

5/4/2010 1:48:00 PM Z:\091601 LFRD Station No. 1\Construction Documents\091601\_01\_ARCH\091601.rvt

**ROOM NAMES - LOWER LEVEL**

- 001 COMM.
- 002 ELECTRICAL
- 003 MECHANICAL
- 004 MECHANICAL
- 005 FITNESS
- 006 STOR.
- 007 UNFINISHED
- C001 CORR.
- S001 STAIR



205 PARKER DRIVE  
LAGRANGE, KY 40031  
502-222-5366 (OFFICE)  
502-222-0021 (FAX)  
www.scott-klausing.com

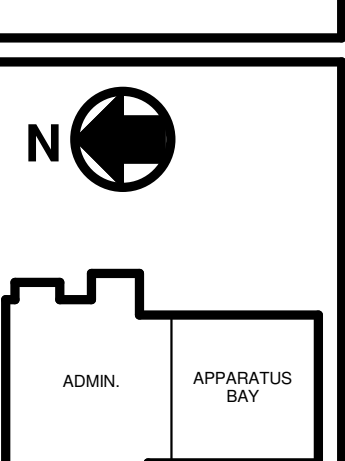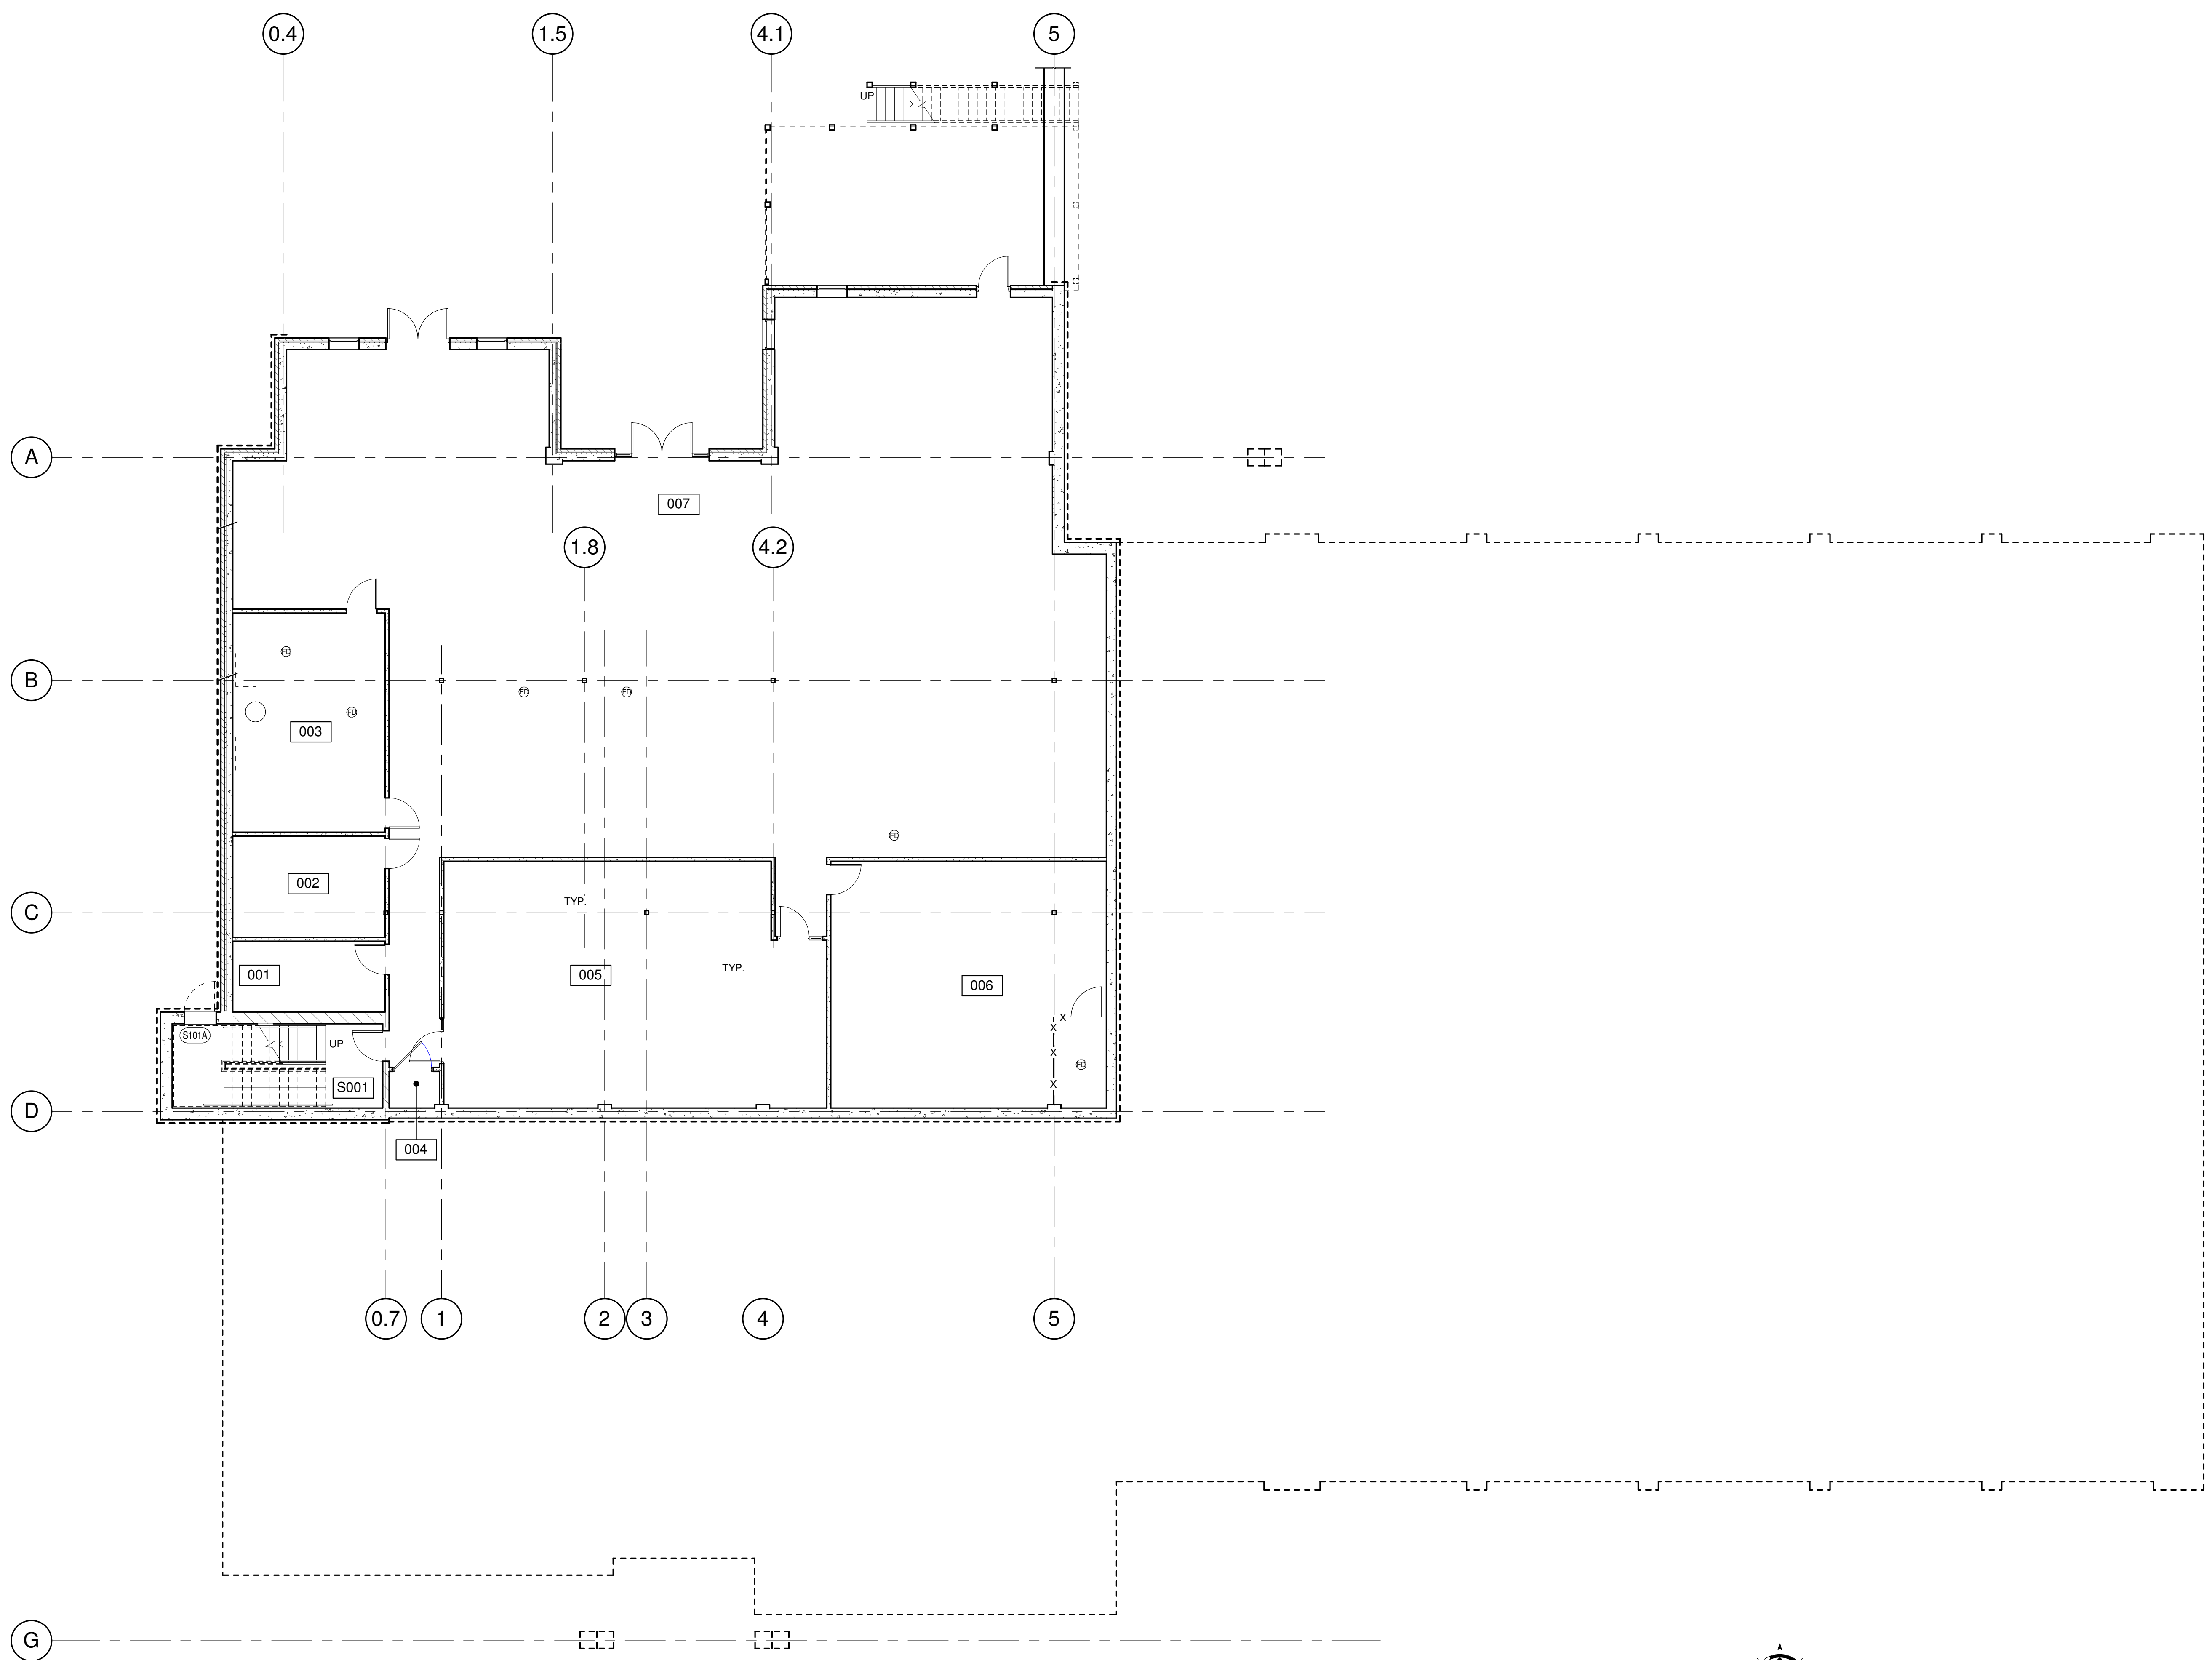

**KEY PLAN**

**LOWER LEVEL FLOOR PLAN**  
STATION NO. 1  
LAGRANGE FIRE AND RESCUE DEPARTMENT  
309 NORTH FIRST STREET  
LAGRANGE, KENTUCKY

DATE	04-22-10
REVISION	
STATUS	

SHEET NO.

**A1**

© SKC INC. 2010

**LOWER LEVEL FLOOR PLAN**  
SCALE: 1/8" = 1'-0"